

圖例 Legend

主幹線 Backbone Section

屯門至上水段 (餘下工程)
Tuen Mun to Sheung Shui Section (Remaining)

●●●●● 擬建的單車徑
Proposed Cycle Tracks

✚ 擬建的休息處
Proposed Resting Station

⚓ 擬建的廁所
Proposed Toilet

其他單車徑項目 Other Cycle Track Projects


— 改善現有單車徑
Improvements to Existing Cycle Tracks

⋯⋯⋯ 新單車徑
New Cycle Tracks

● 匯合中心
Entry / Exit Hub

✚ 休息處
Resting Station

⚓ 廁所
Toilet

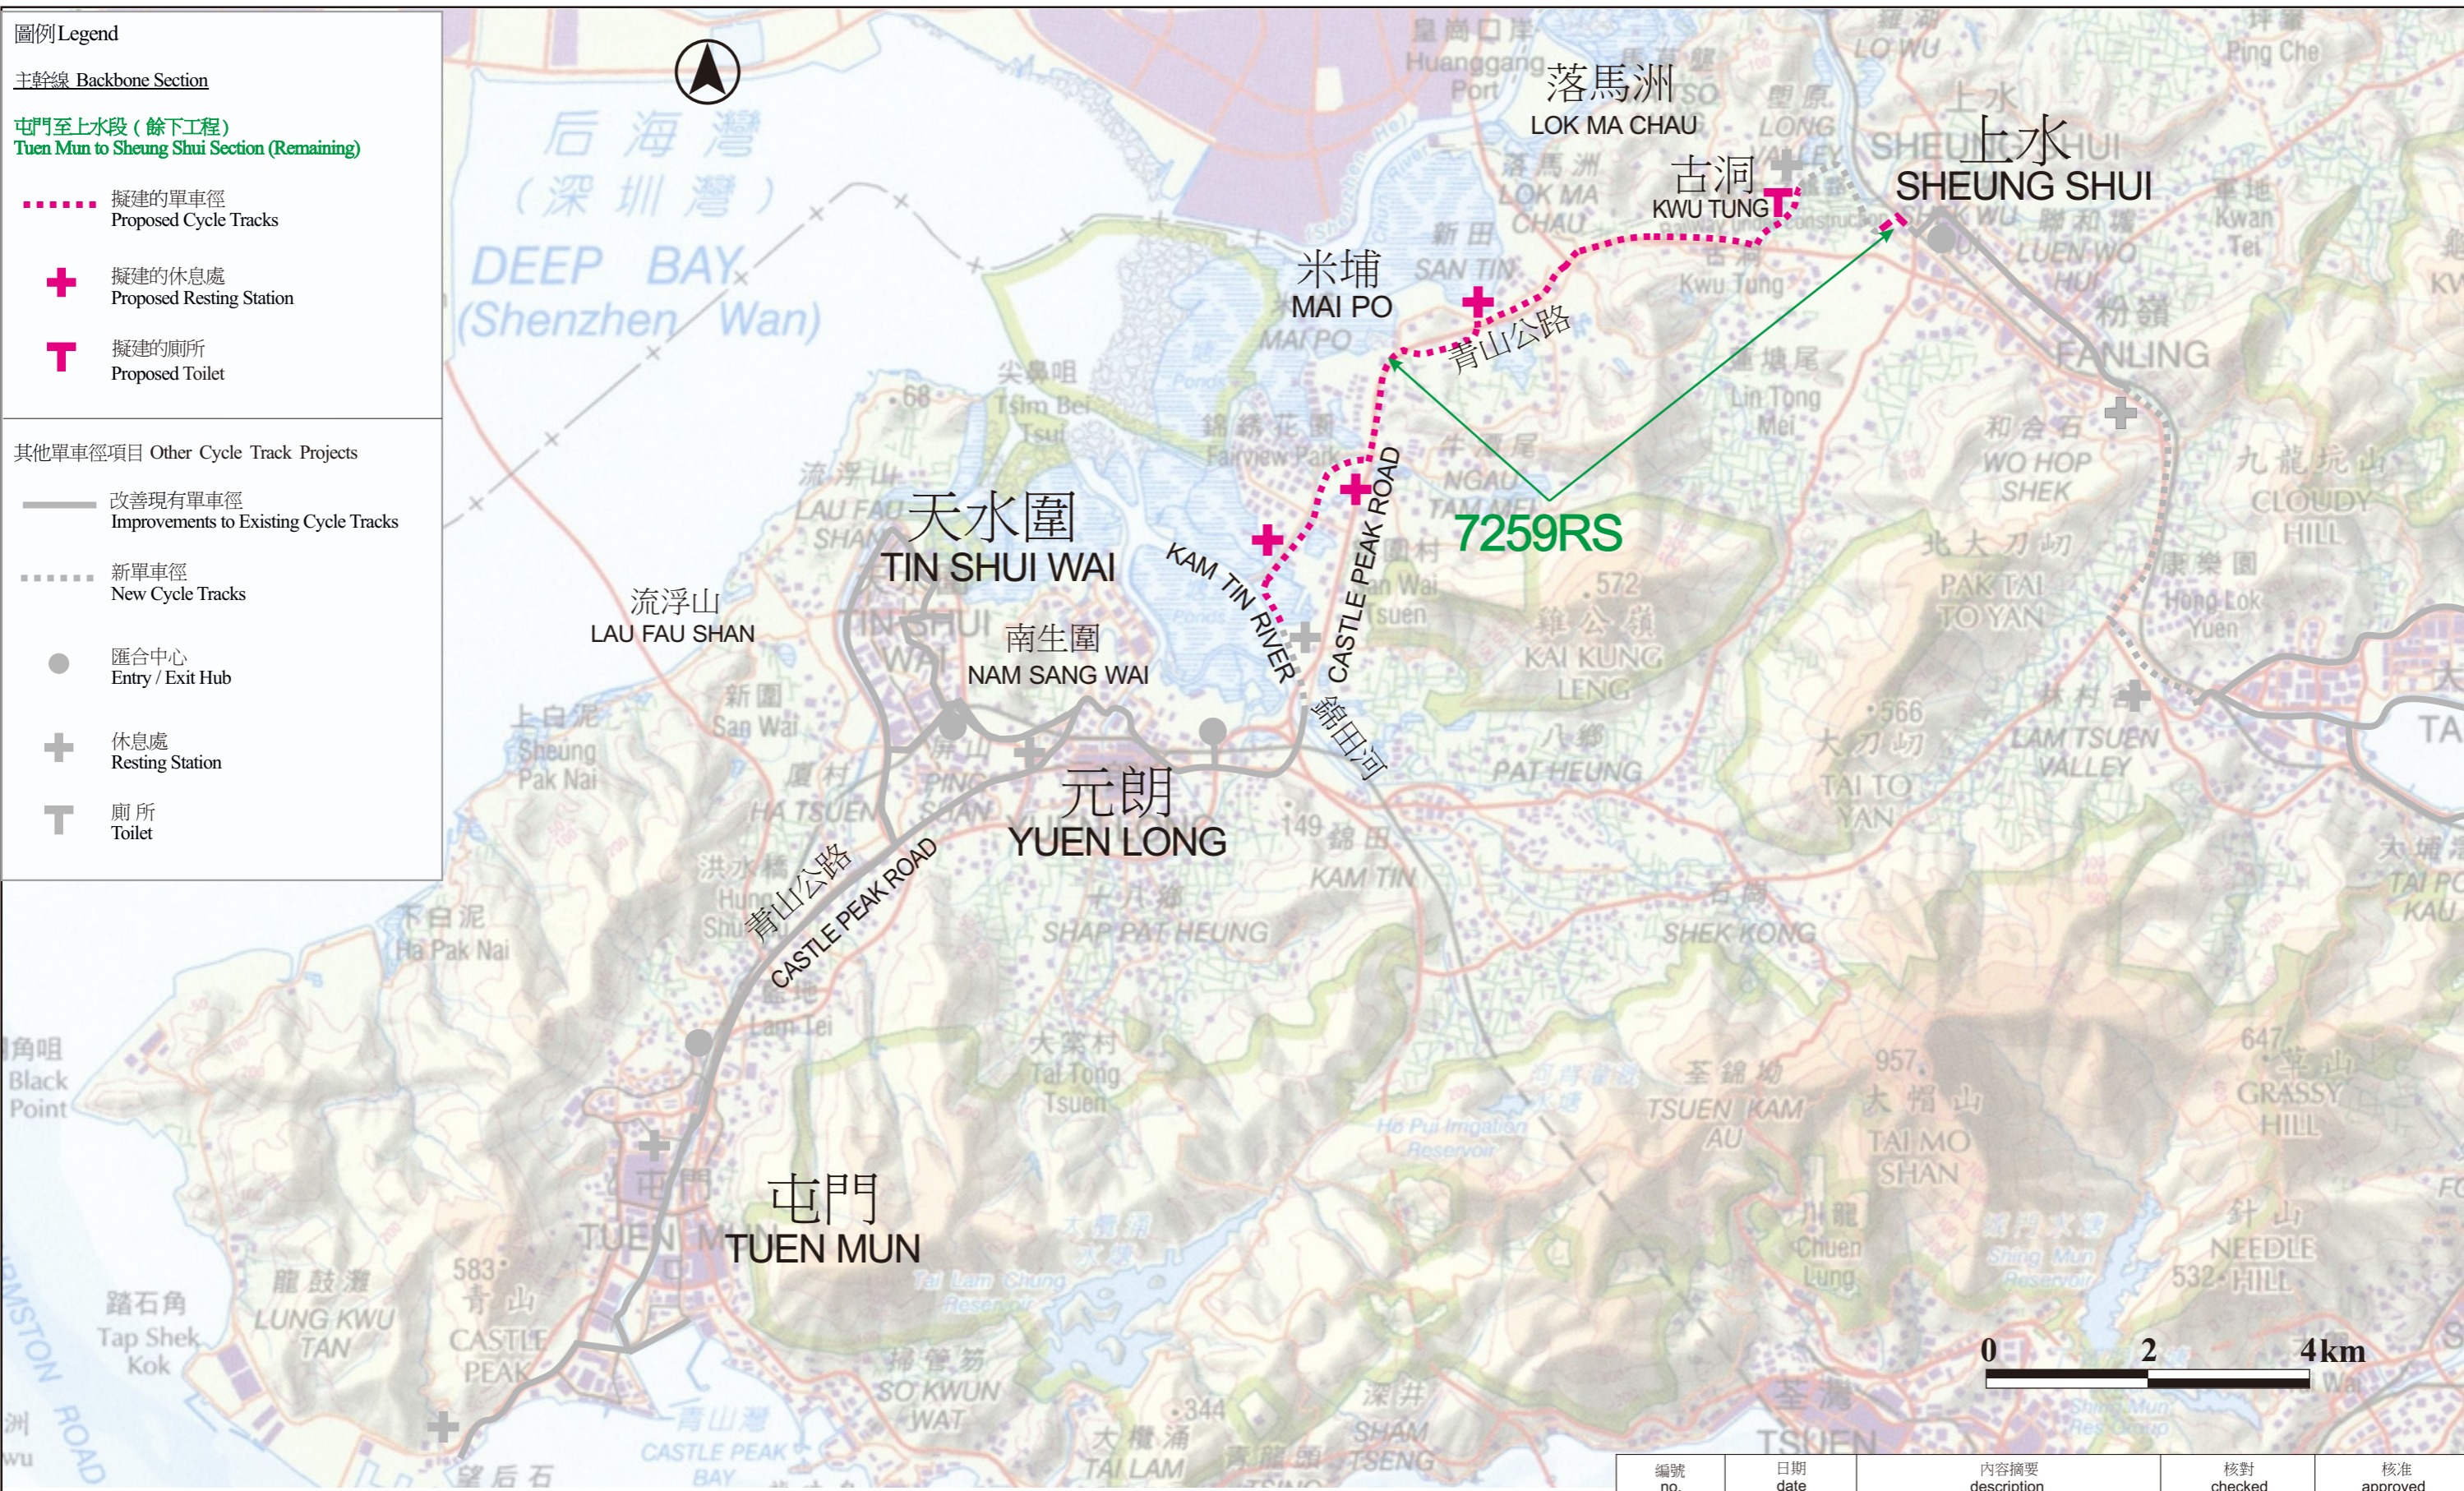

圖則名稱 drawing title
 工務計劃項目第7259RS號 - 連接新界西北及新界東北之單車徑－屯門至上水段 (餘下工程)
 PWP ITEM 7259RS - CYCLE TRACKS CONNECTING NORTH WEST NEW TERRITORIES WITH NORTH EAST NEW TERRITORIES - TUEN MUN TO SHEUNG SHUI SECTION (REMAINING)

繪圖 drawn	簽署 initial	日期 date	項目編號 item no.
T.C. Tsang		22.02.2018	7259RS
核對 checked	簽署 initial	日期 date	比例 scale
C.H. Chiu		22.02.2018	AS SHOWN
核准 approved	簽署 initial	日期 date	圖則編號 drawing no.
W.L. Chu		22.02.2018	WDOTW-Z0020

內容摘要 description	核對 checked	核准 approved
辦事處 office		
西拓展處 WEST DEVELOPMENT OFFICE		
 土木工程拓展署 CIVIL ENGINEERING AND DEVELOPMENT DEPARTMENT		